



GROUND FLR. PLAN AND  
2ND FLR. FRAMING PLAN

FLOOR PLAN @ REC. RM.  
SCALE: 1/4"=1'-0"

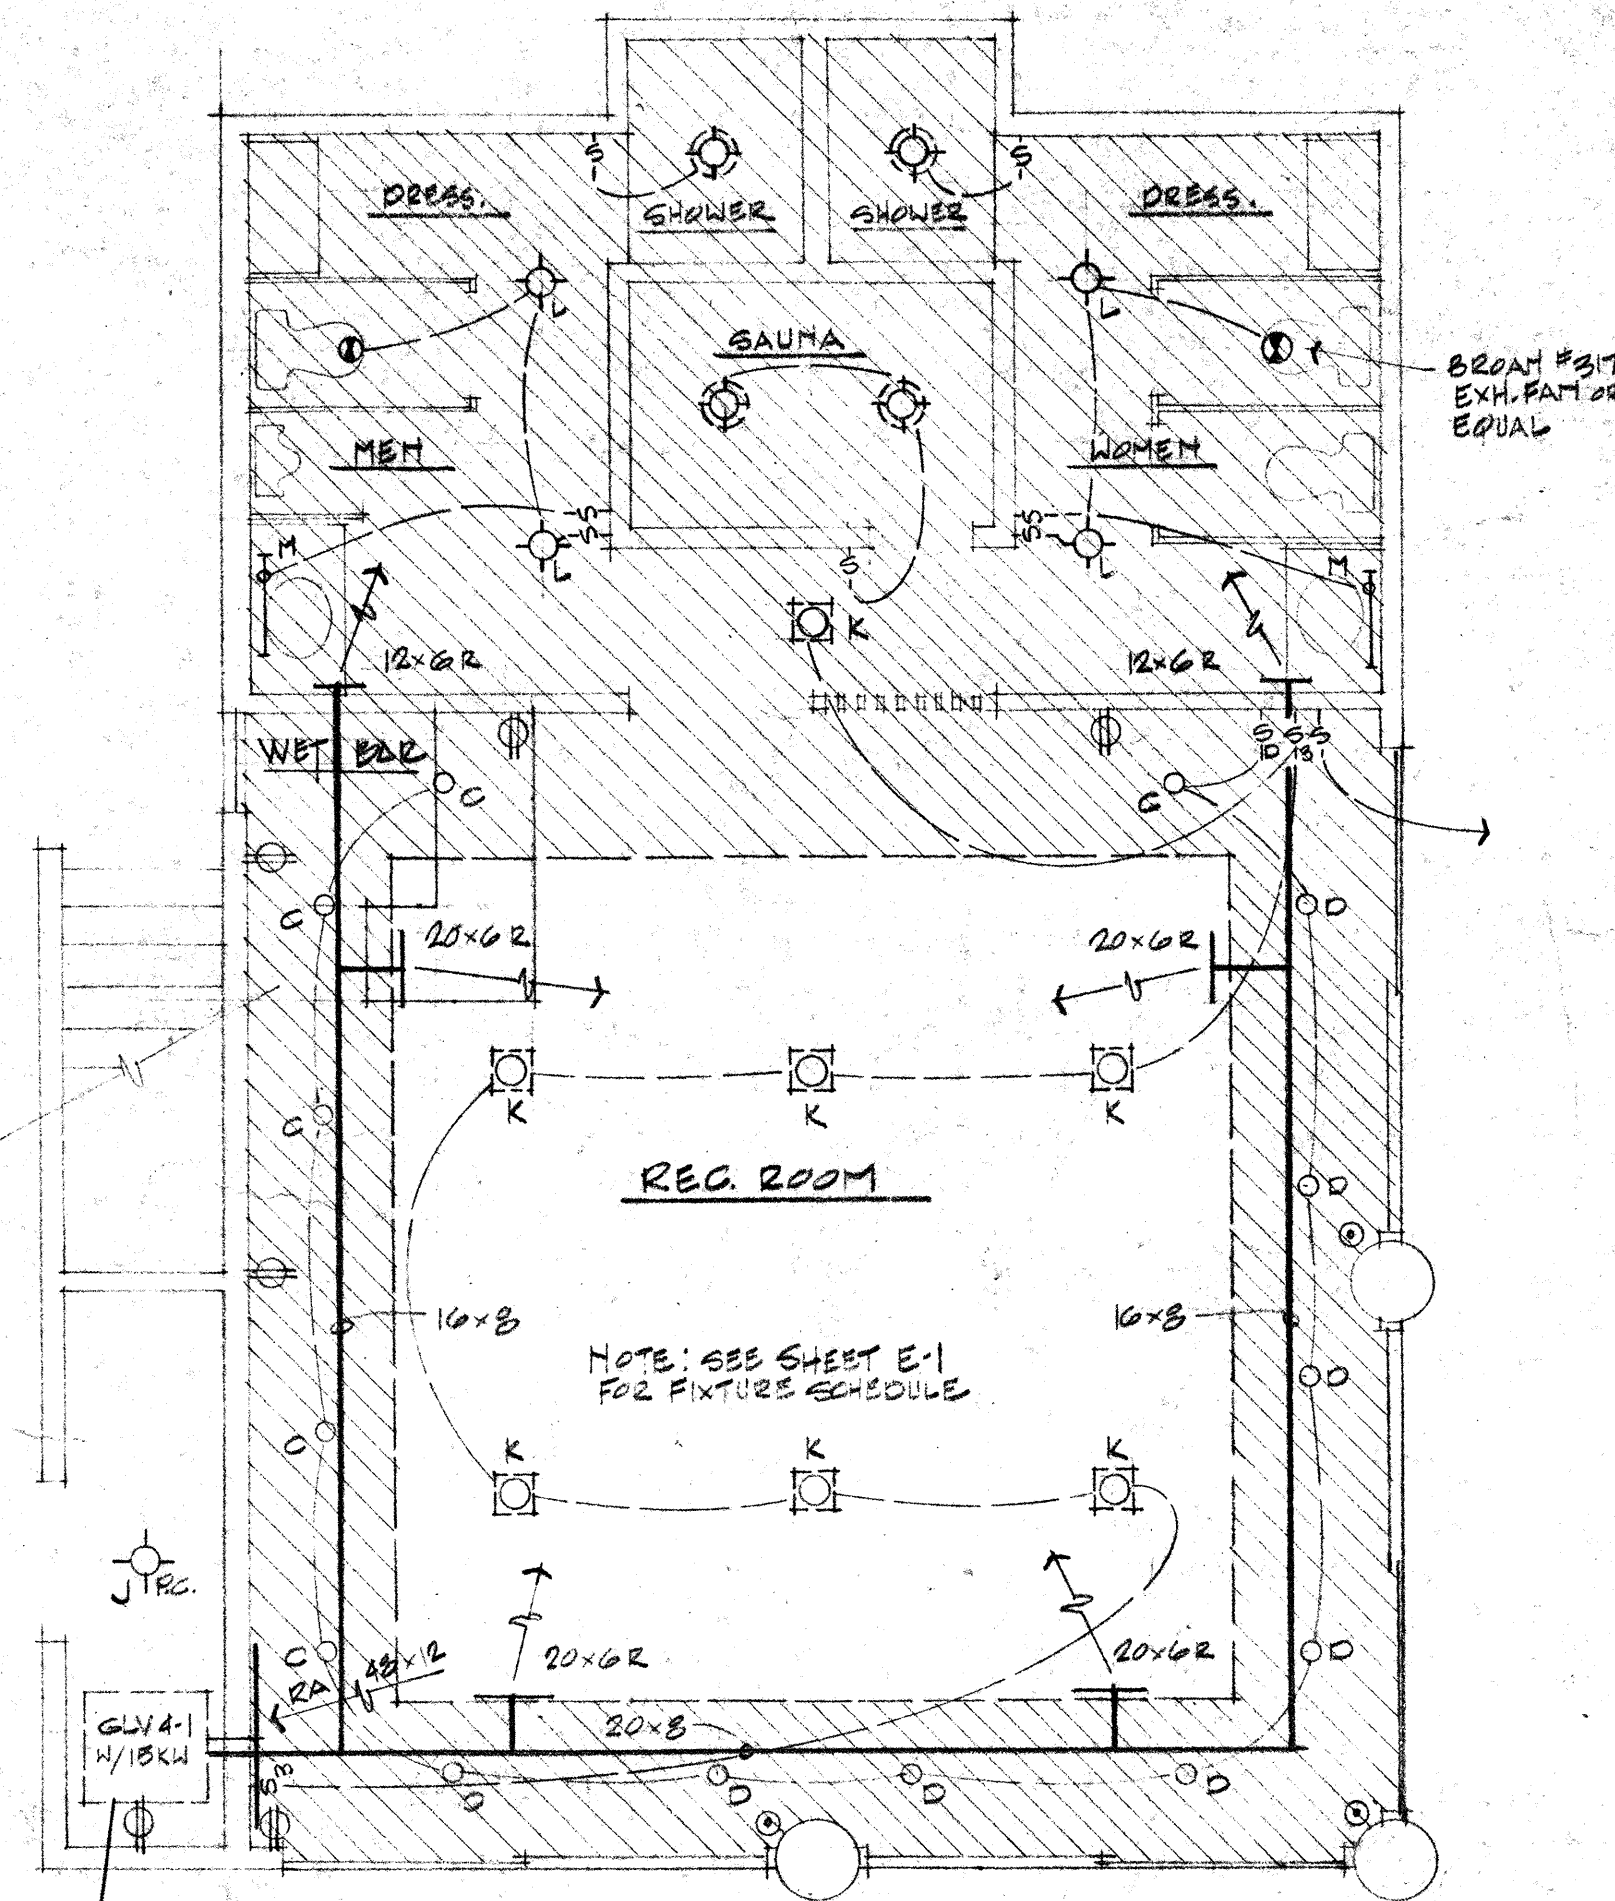

ELECTRICAL/MECHANICAL PLAN @ REC. RM.  
SCALE 1/4"=1'-0"

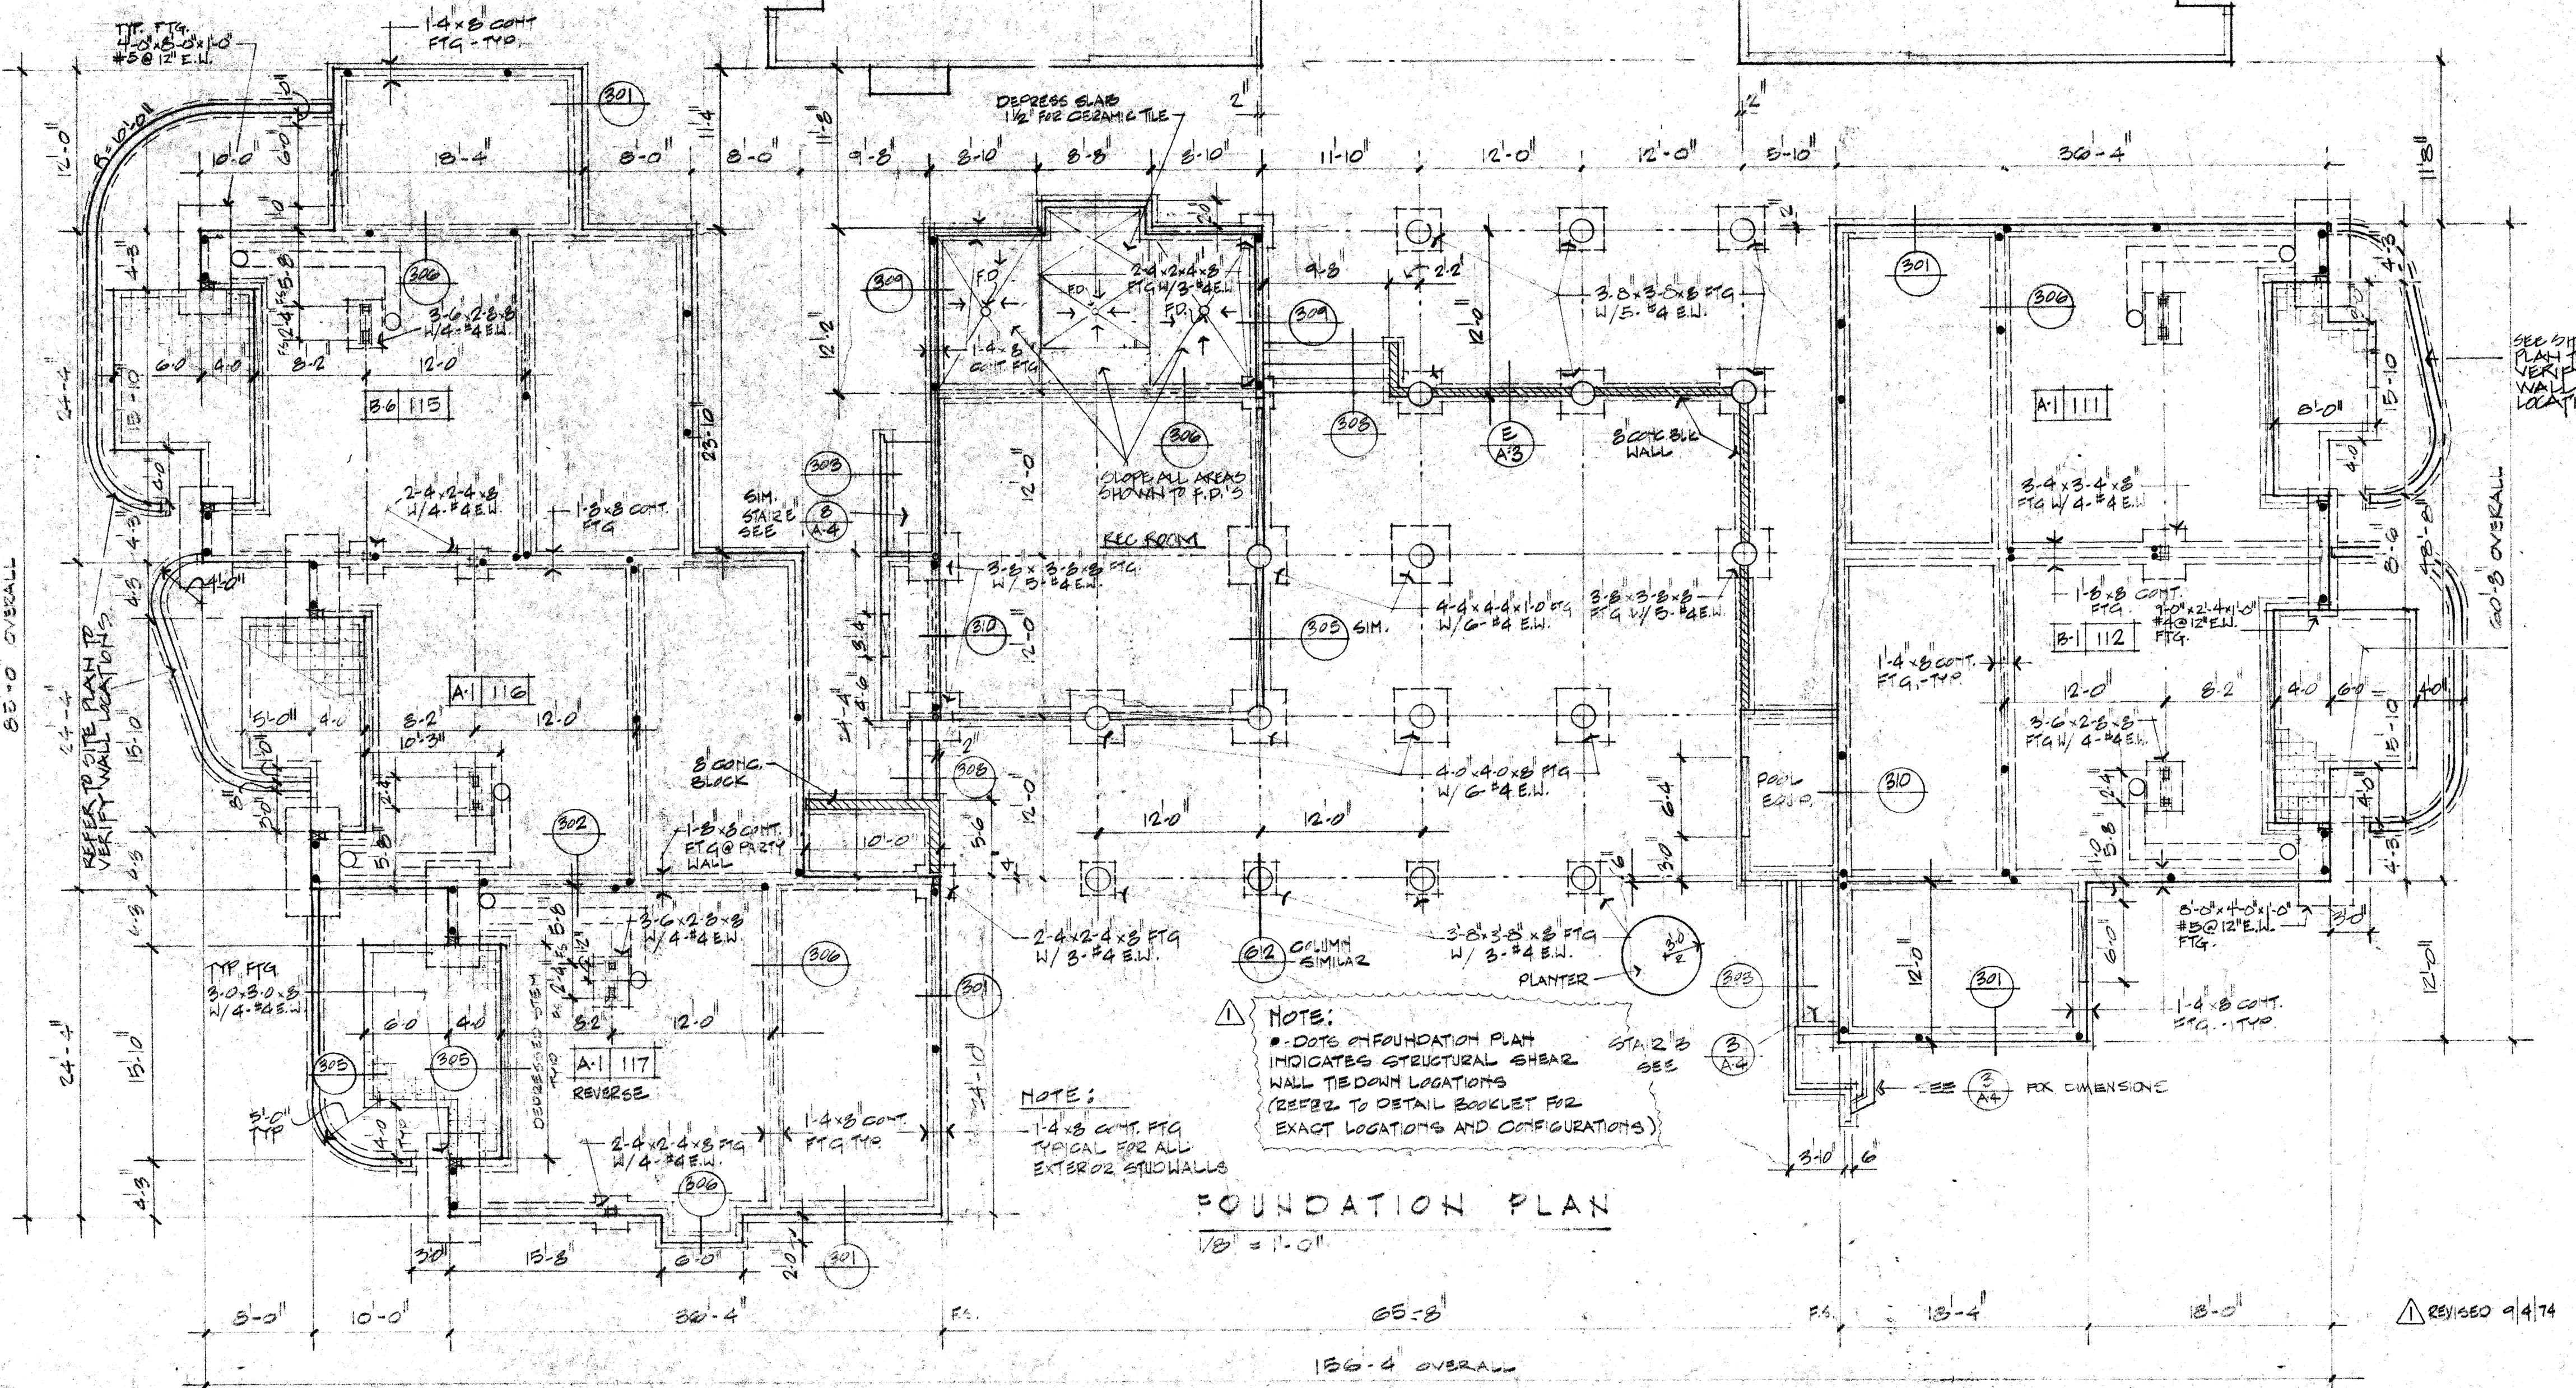

FOUNDATION PLAN  
1/8"=1'-0"

SAND CASTLE APTES  
STAMAH, THOMAS AND COMPANY  
1121 E. SANDRIER DR., TEMPE, ARIZ.  
1213 E. PLACIO DR., PHX., ARIZ.

BLDG # 3

A  
15

SCHONBERGER, STRAUB, FLORENCE AND ASSOCIATES ARCHITECTS INCORPORATED  
PHOENIX, ARIZONA  
MEMBER AMERICAN INSTITUTE OF ARCHITECTS